

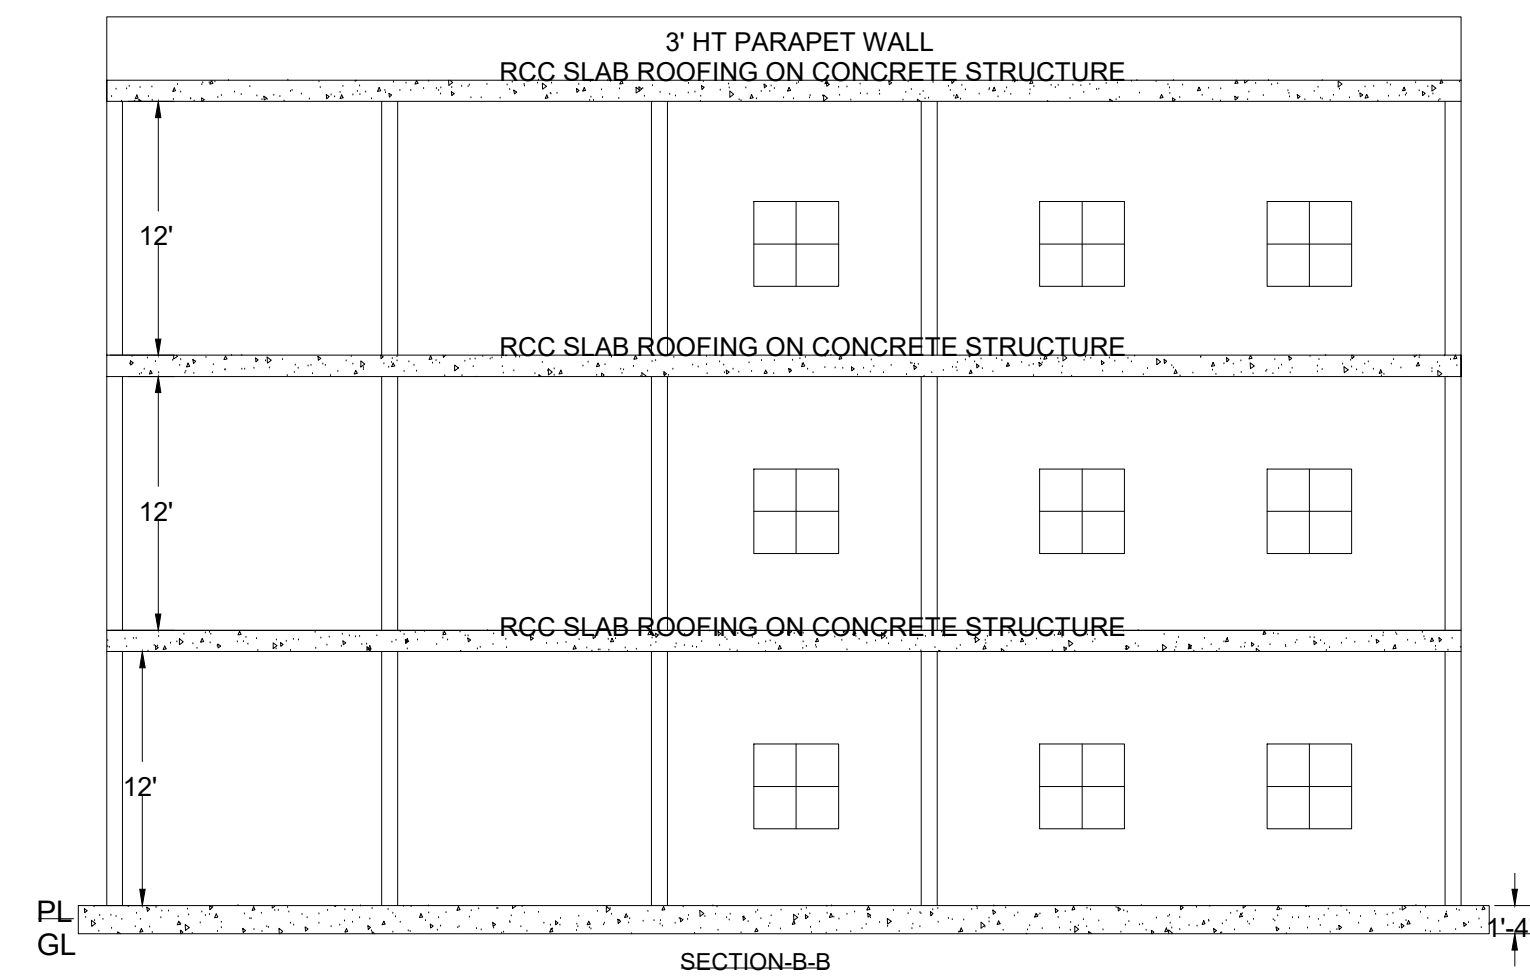
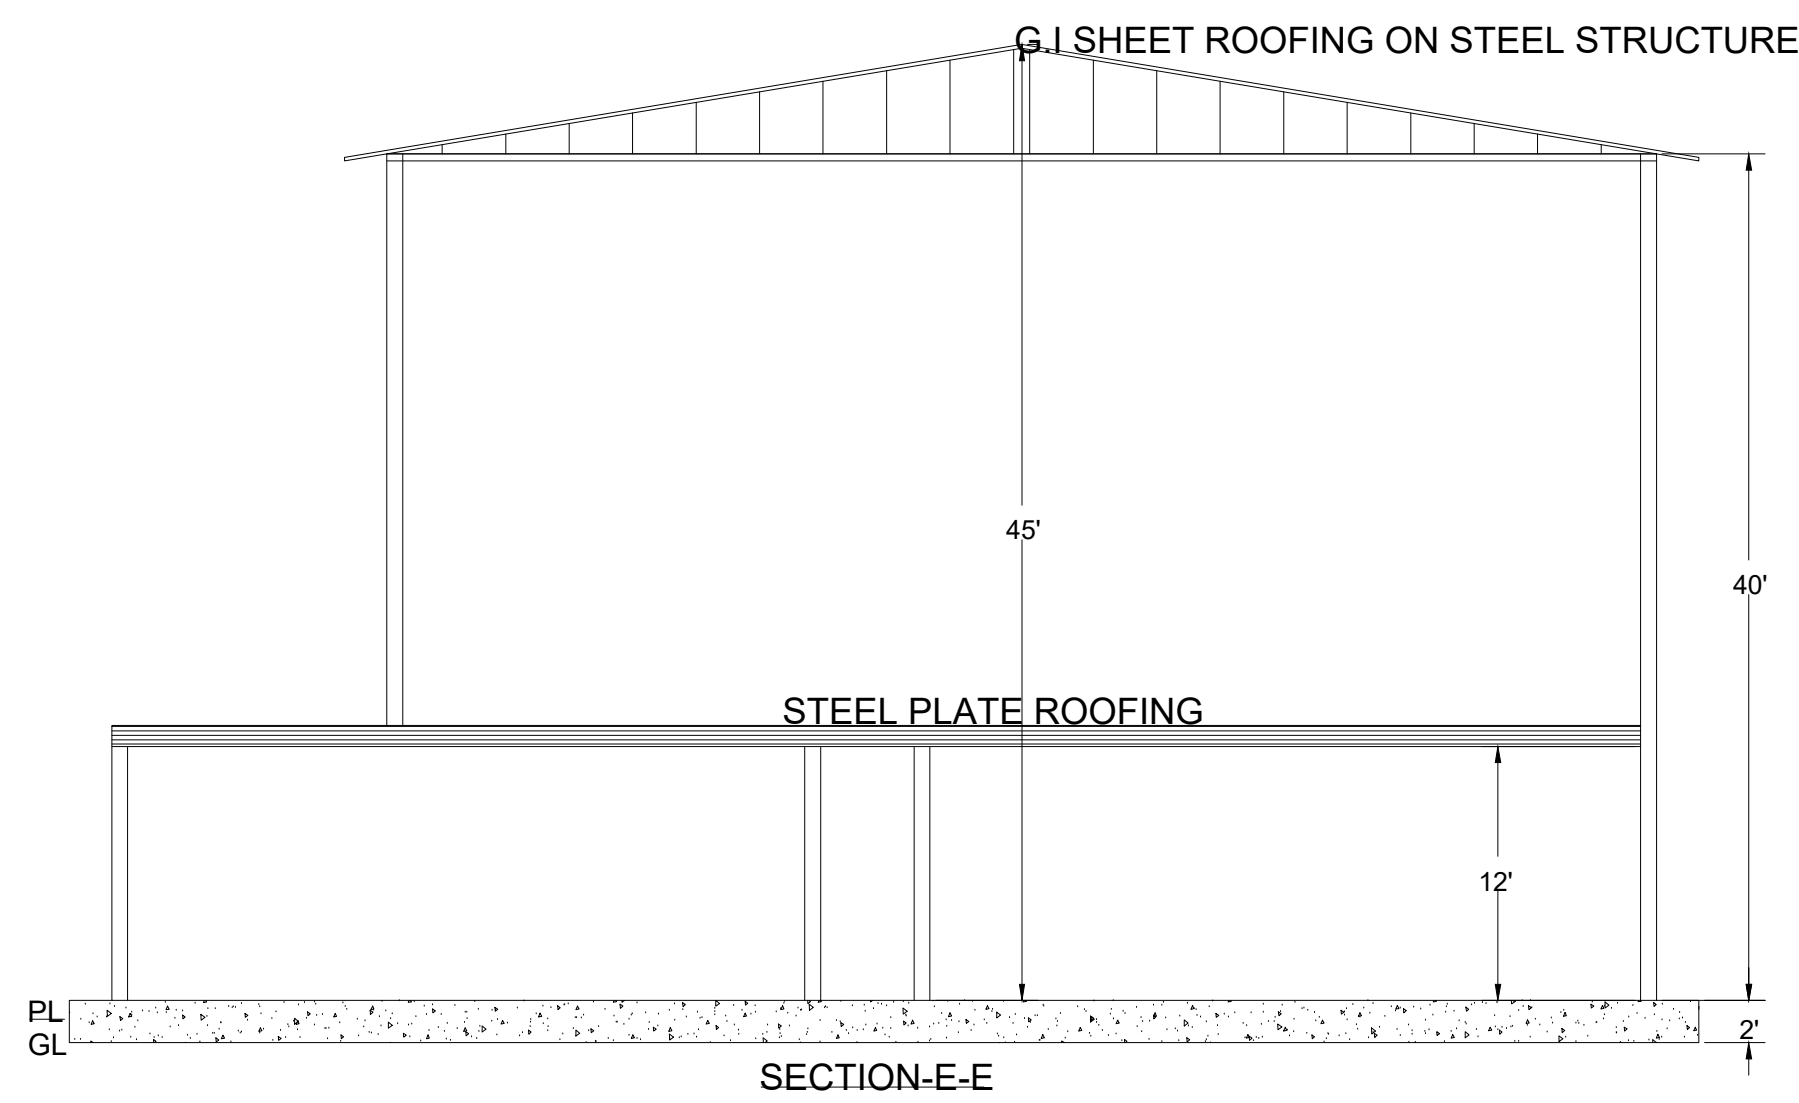
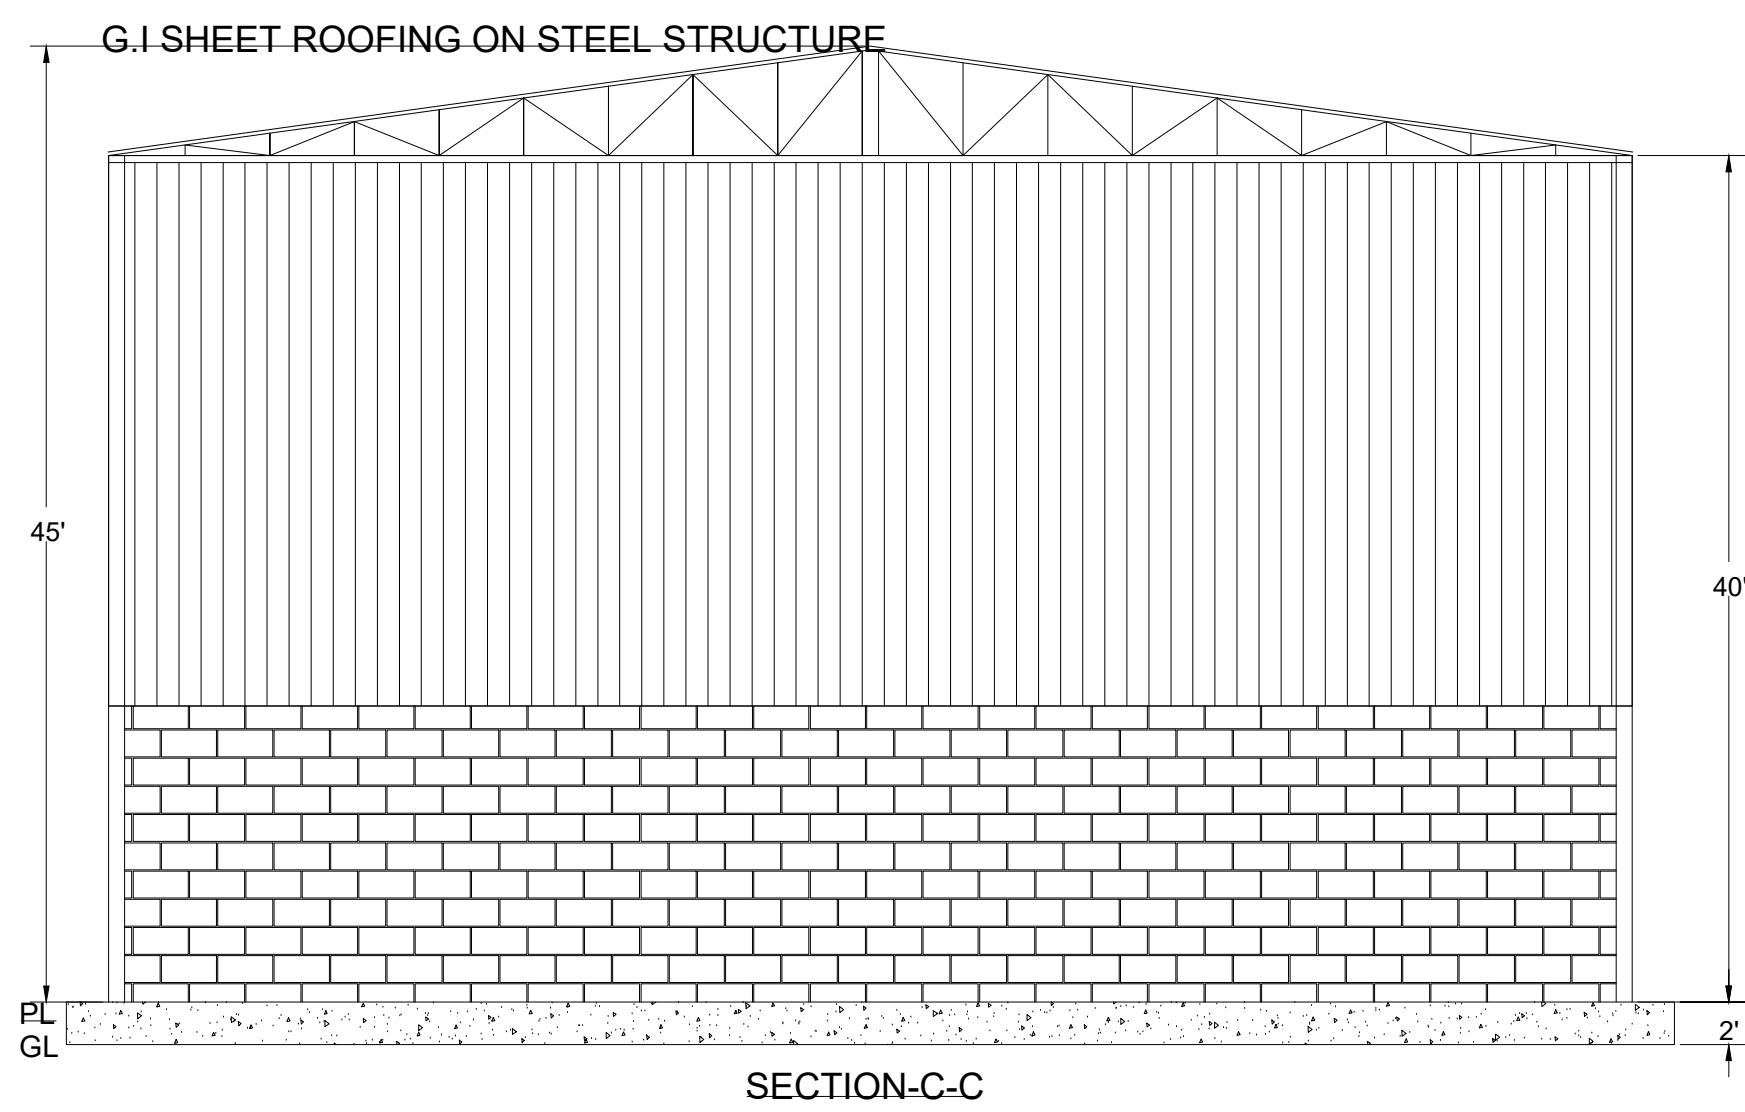


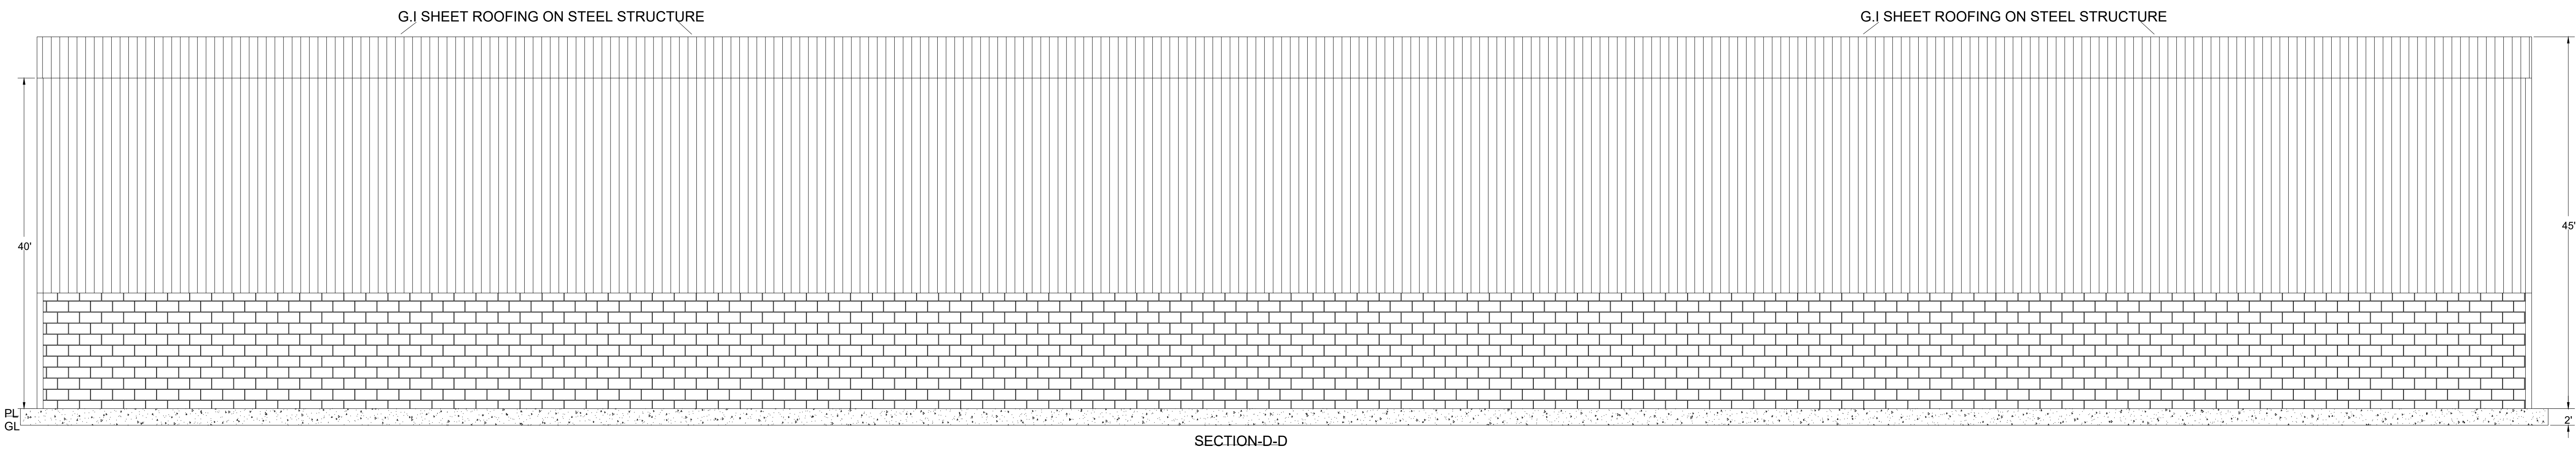

EXISTING NEW FACTORY PLAN OF -
M/S HILLWAYS CONSTRUCTION COMPANY PVT LTD.
C1, MUNI KI RETI, DHALWALA, RISHIKESH,
TEHRI GARHWAL, UTTARAKHAND.

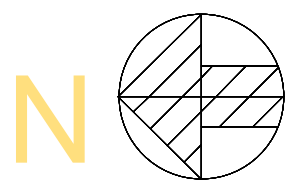

DRG NO. - AB-HL-114/2026

SCALE - 1' = 10'-0"

SHEET NO. 3/3

DETAIL OF DOOR & WINDOWS

D- DOOR---3' X 7'
D1- DOOR---2'5" X 7'
W- WINDOW-4' X 4'
W1- WINDOW-6' X 5'
V- VENTILATOR -2' X 1'








AB PLANNERS & ENG.
LAND CRAFT METRO HOMES
DUHAI, GHAZIABAD, UTTAR PRADESH.
Mail ID : anay.anay16@gmail.com
CONTACT NO. 8171292866.

PREPARED BY : ABHINAV SRIVASTAVA

SIG OF OCCUPIER

SIG OF MANAGER

DETAIL PLAN

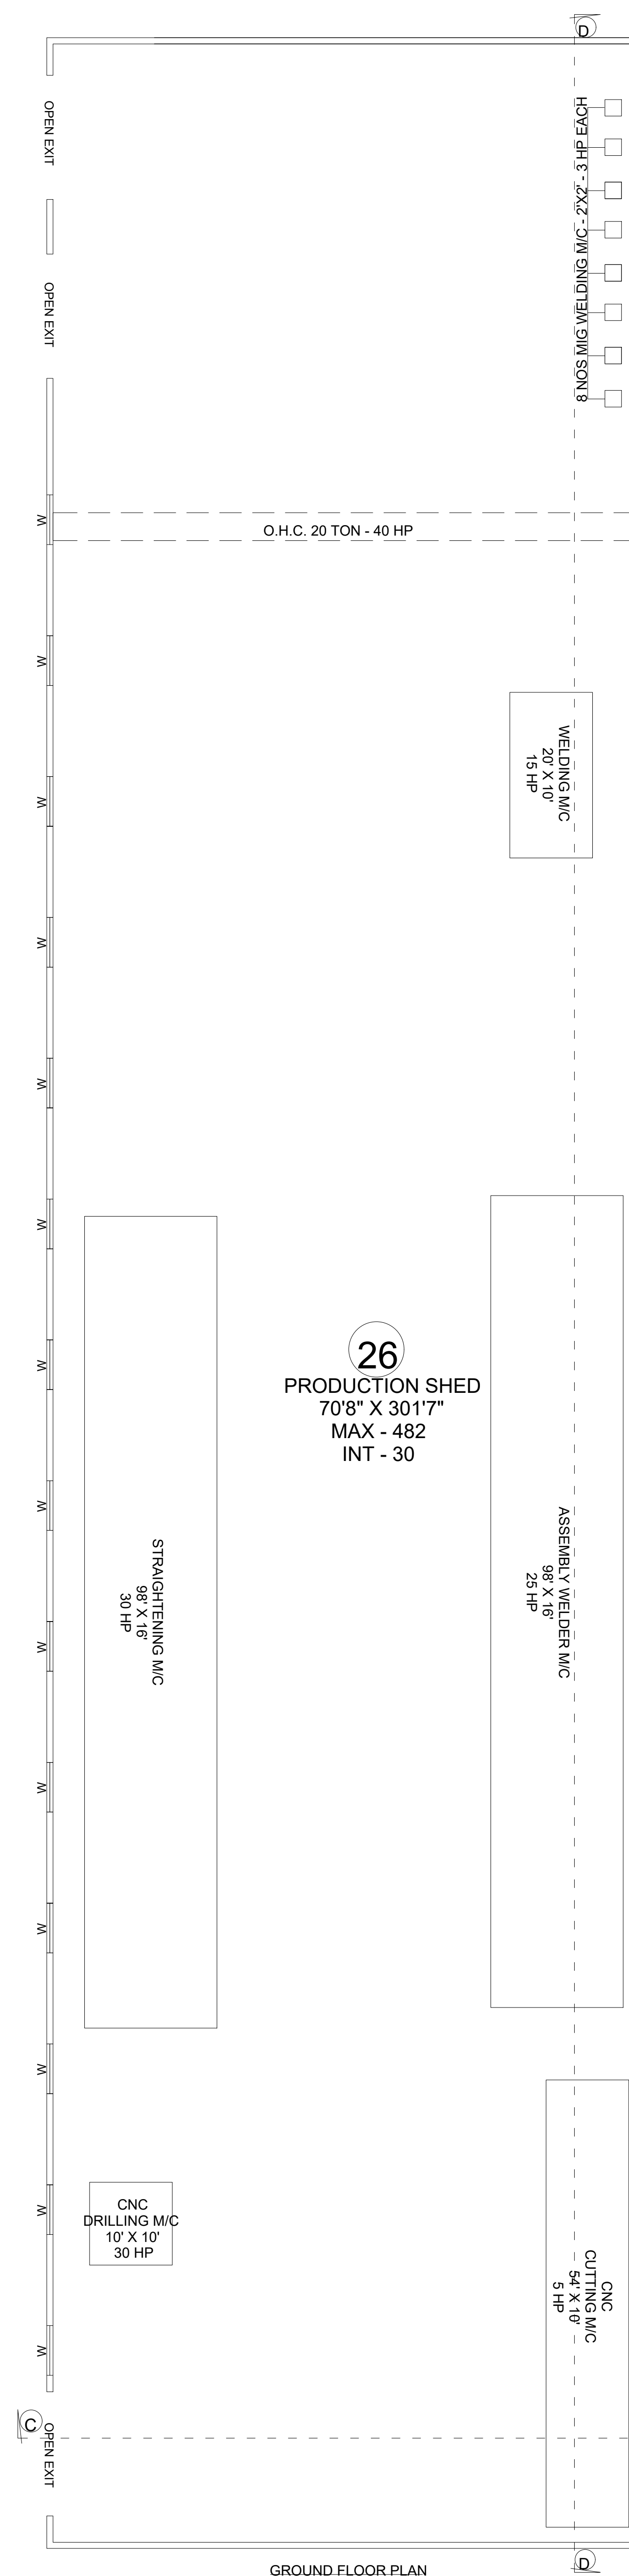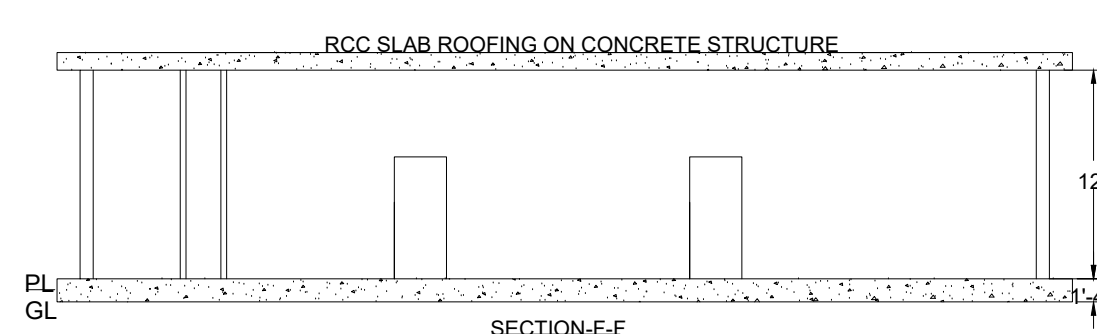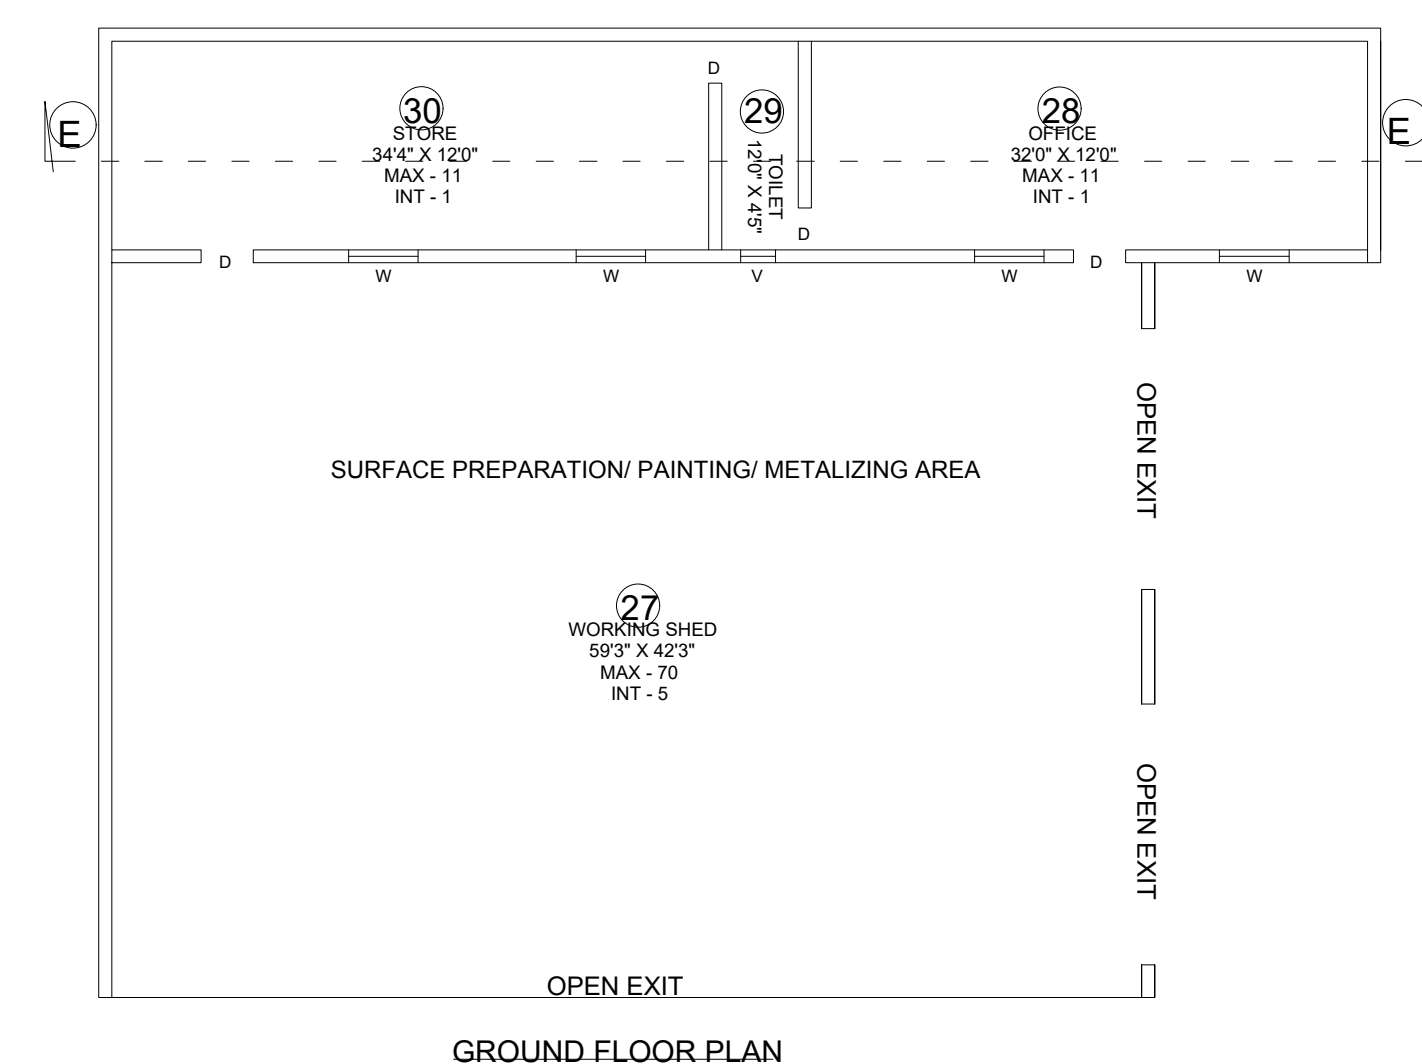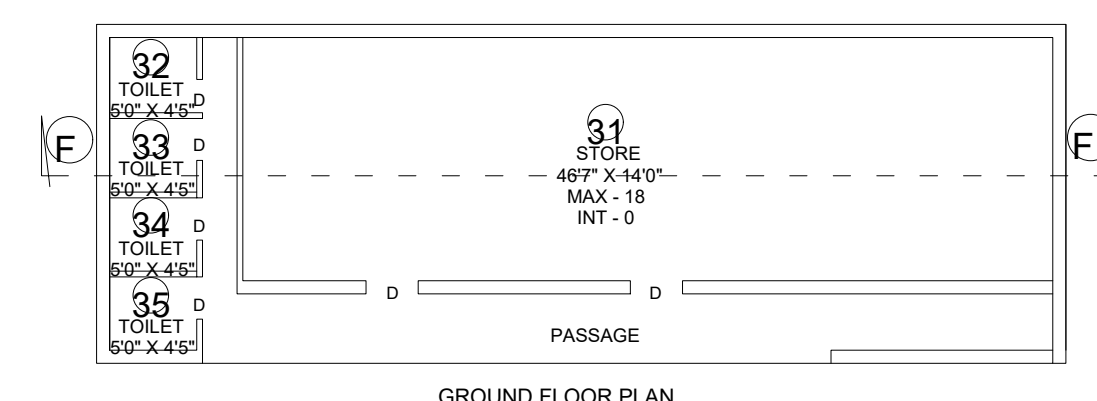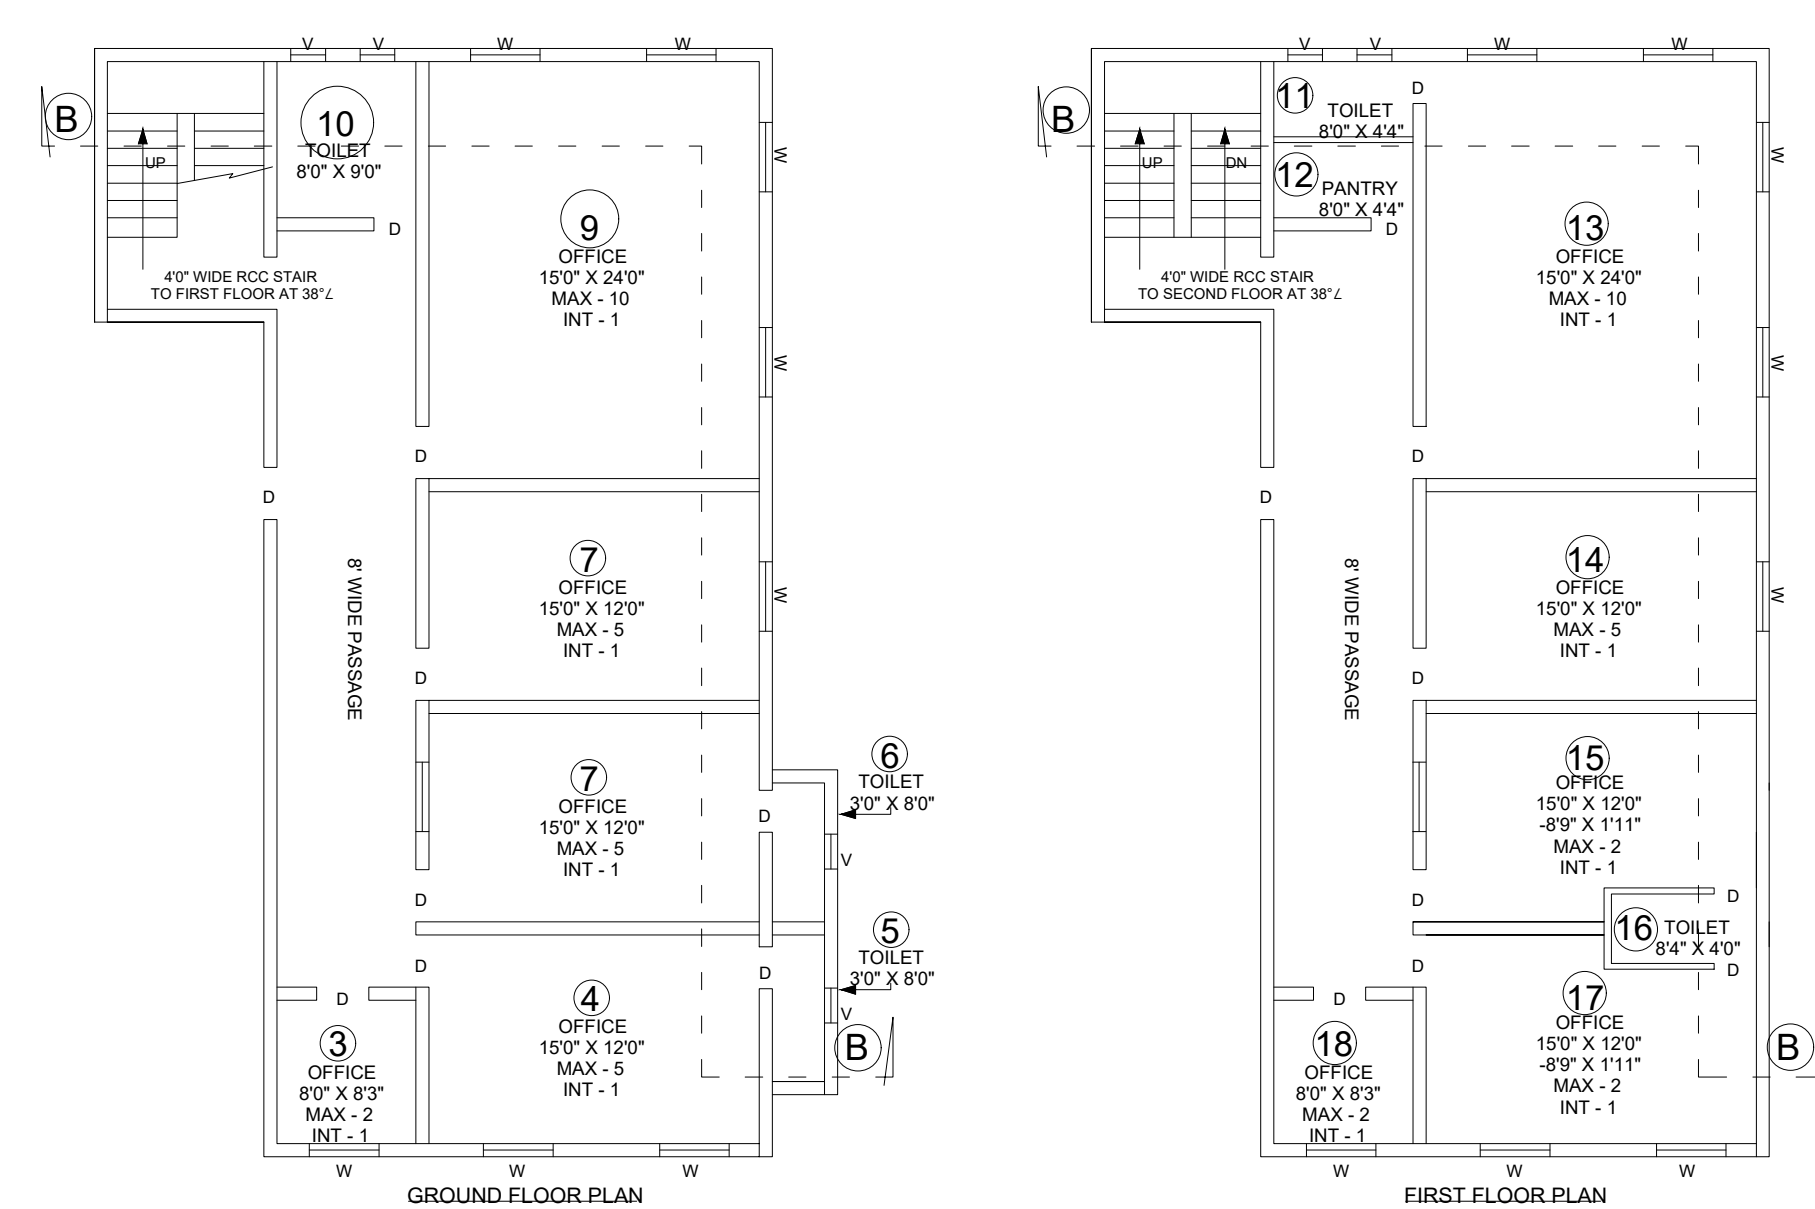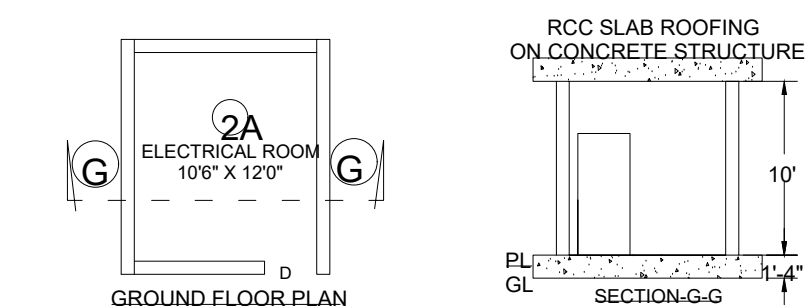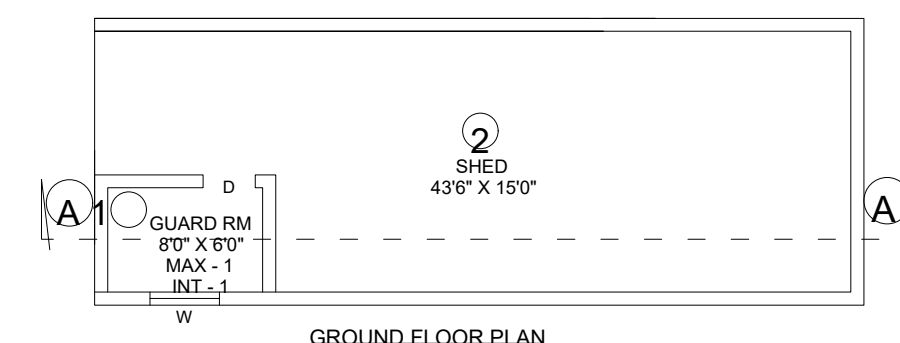


N

SHEET NO. 2/3

D- DOOR---3' X 7'
D1- DOOR---2'5" X 7'
W- WINDOW-4' X 4'
W1- WINDOW-6' X 5'
V- VENTILATOR -2'


PREPARED BY : ABHINAY SRIVASTAVA

SIG OF MANAGER

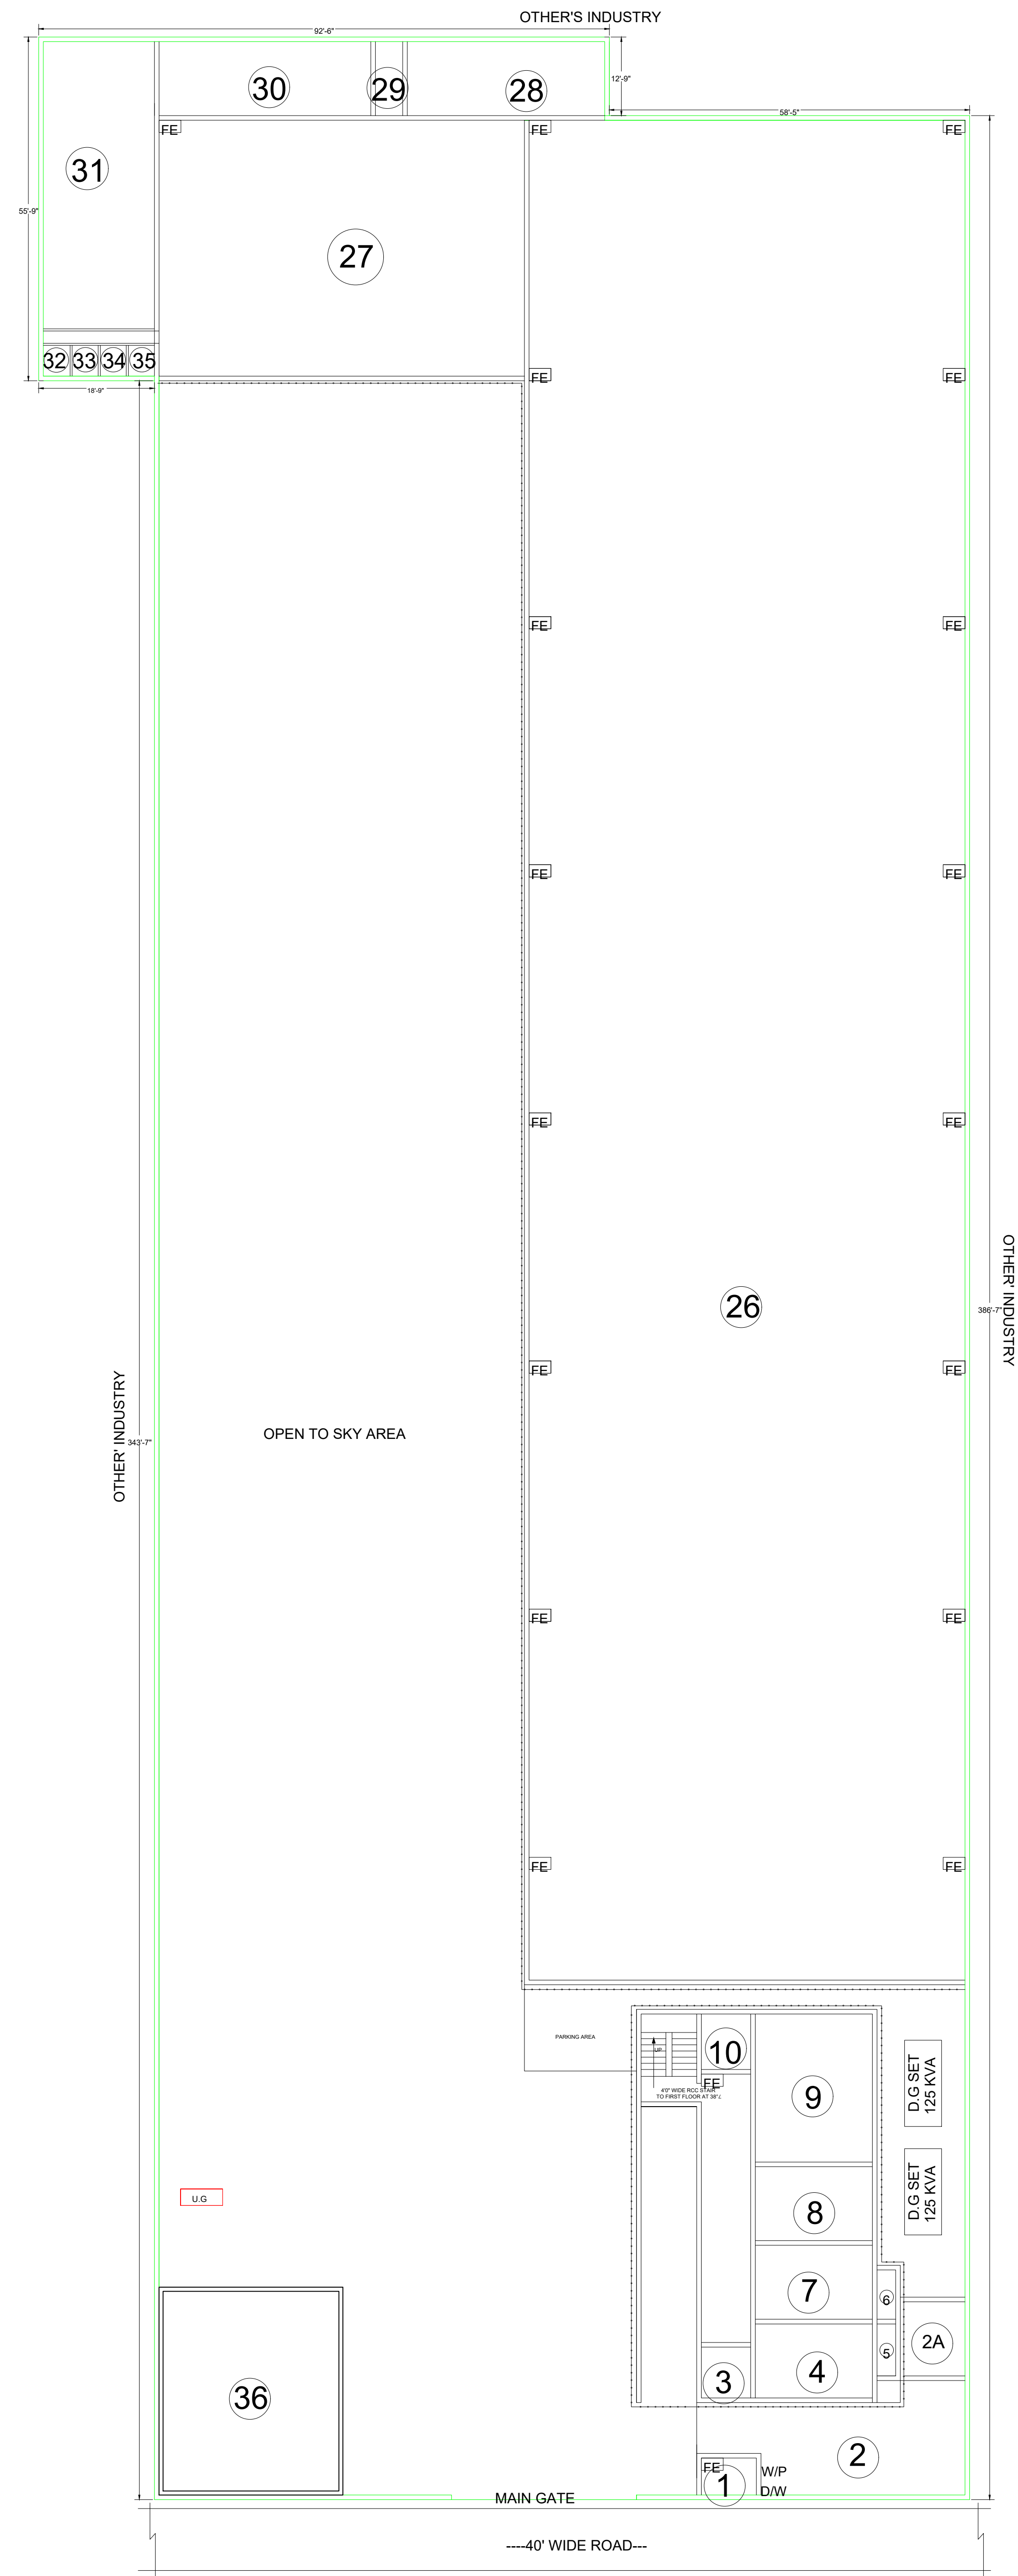

SITE PLAN

EXISTING NEW FACTORY PLAN OF -
M/S HILLWAYS CONSTRUCTION COMPANY PVT.LTD.
C1, MUNI KI RETI, DHALWALA, RISHIKESH,
TEHRI GARHWAL, UTTARAKHAND.

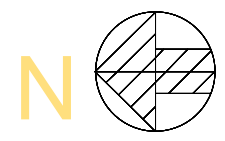

DRG NO. - AB-HL-114/2026
SCALE - 1" = 10'-0"
SHEET NO. 1/3

INDEX:-

FACTORY PREMISES SHOWN AS	
DRAINAGE LINE SHOWN AS	
FIRE EXTINGUISHER SHOWN AS	FE
WASHING PLACE SHOWN AS	W/P
DRINKING WATER SHOWN AS	D/W
UNDER GROUND WATER TANK SHOWN AS	U.G.

INDEX:-

DISTANCE OF THE FIRE STATION	8.0 K.M.
DISTANCE OF THE POLICE STATION	3.0 K.M.
DISTANCE OF THE EDUCATION	5.0 K.M.
DISTANCE OF THE HOSPITAL	3.0 K.M.
DISTANCE OF THE POPULATION	0.5 K.M.
DISTANCE OF THE PETROL PUMP	2.0 K.M.

DETAIL OF DOOR & WINDOWS
D- DOOR--3' X 7'
D1- DOOR--2'5" X 7"
W- WINDOW-4' X 4'
W1- WINDOW-6' X 5'
V- VENTILATOR -2' X 1'

DETAIL OF ELECTRIC POWER
ELECTRIC POWER INSTALLED - 179.0 HP
D.G POWER- 125 + 125 = 250 KVA (STAND BY)

TOTAL AREA - 4226 SQM
COVERED AREA -2700 SQM
SRNO-30 IS THE STORAGE AREA
SR NO 26 IS THE MACHINE POSITION AREA
SR NO 36 IS THE PAINTING/METALIZING AREA

AB PLANNERS & ENG.
LAND CRAFT METRO HOMES
DUHA, GHAZIABAD, UTTAR PRADESH.
Mail ID : anay.anay16@gmail.com
CONTACT NO. 8171292866.
PREPARED BY :- ABHINAY SRIVASTAVA

SIG.OF OCCUPIER

SIG.OF MANAGER